
 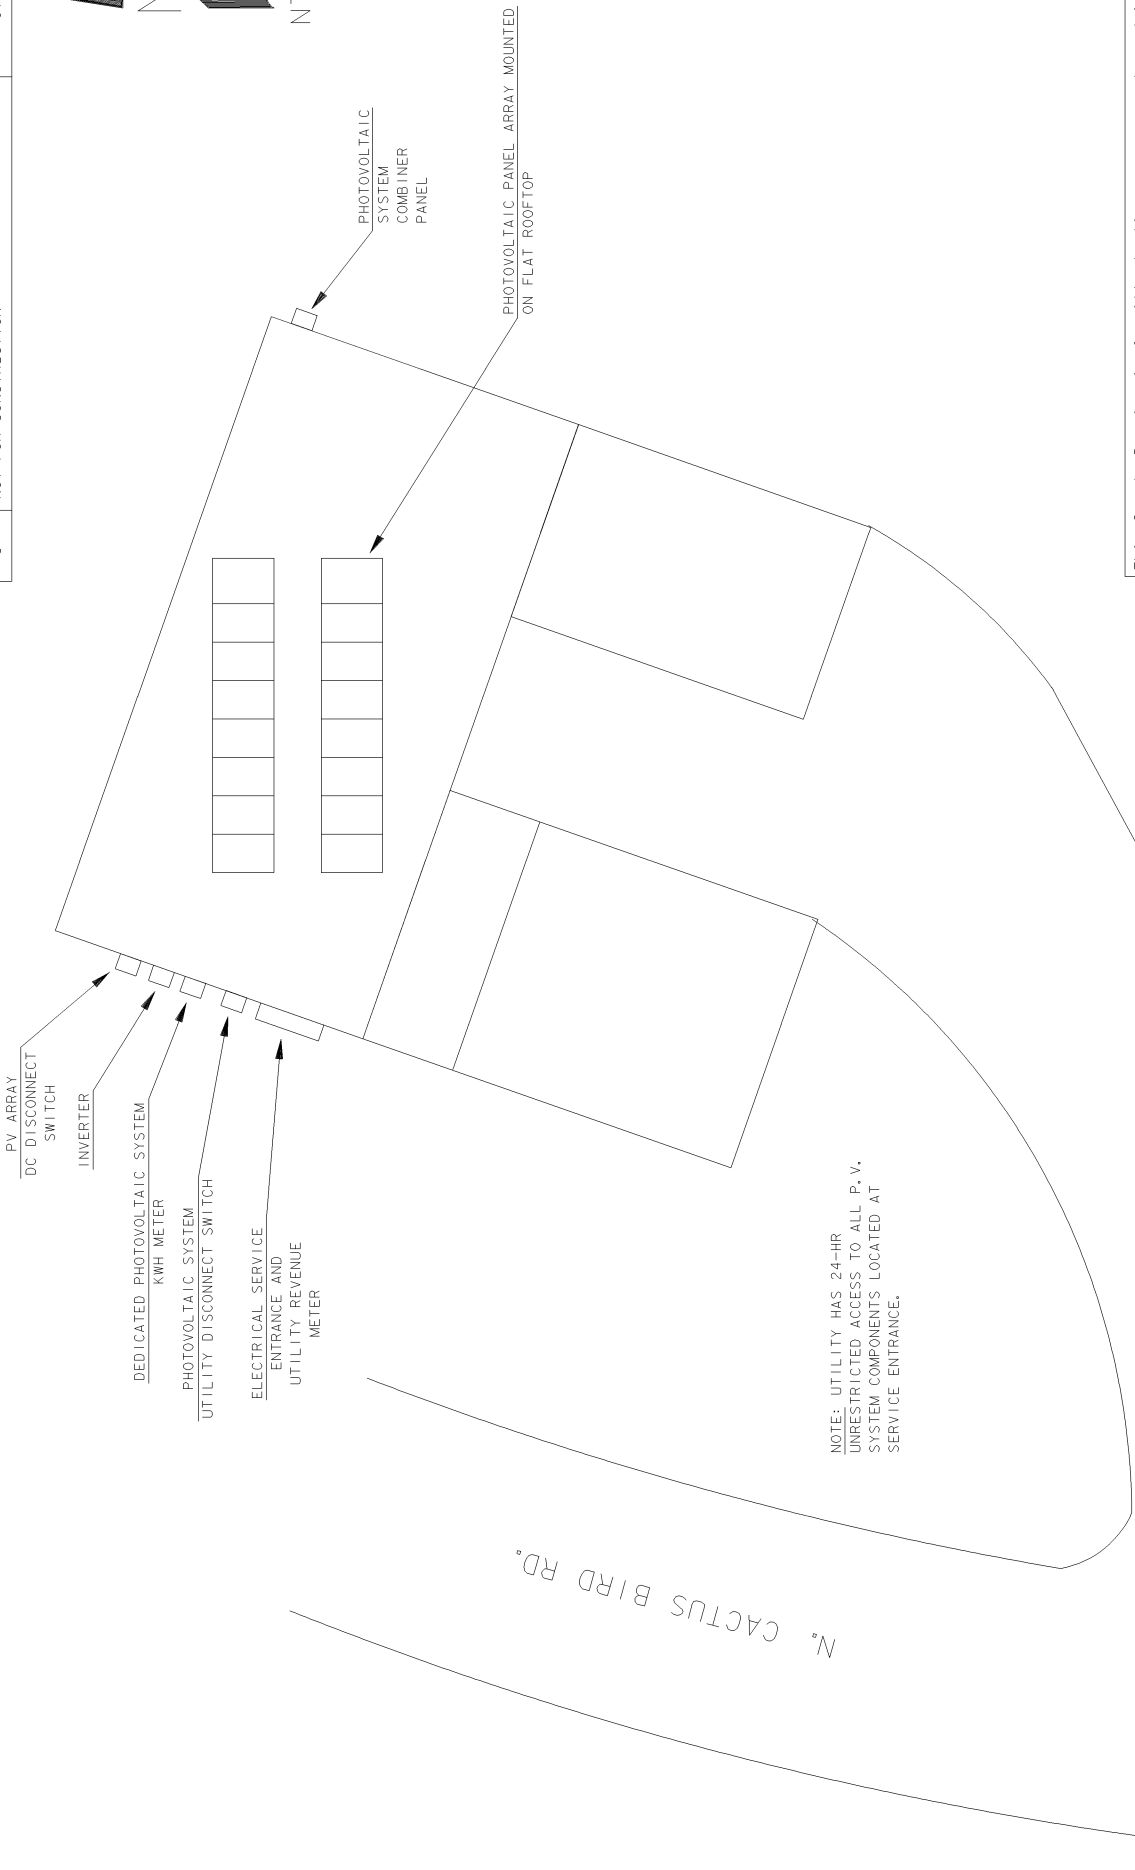


REV.	DESCRIPTION	DATE
C	NOT FOR CONSTRUCTION	01-29-07



NOTE: UTILITY HAS 24-HR UNRESTRICTED ACCESS TO ALL P. V. SYSTEM COMPONENTS LOCATED AT SERVICE ENTRANCE.

This Sample Drawing is for illustration purposes only and is not to be used for design or construction. This drawing and its suitability for end use is not implied. The intent is only to illustrate typical minimum information required at time of application to SRP. Additional information may be required.

SAMPLE SITE PLAN

1234 South Main Street Any City Arizona 85123 Tel: 602-555-5555		ABC SOLAR COMPANY, INC.	
APPROVALS	DATE	4.8 KW PHOTOVOLTAIC SYSTEM 999 N. CACTUS BIRD RD ANY CITY, AZ 85123	
DRAWN ABC	04-20-04	SIZE	CODE INTENT NO.
CHECKED		A	000-0005
ENGINEER		SCALE	REV. C
M.C.R.		DO NOT SCALE DRAWINGS	
REV. C	01-29-07	DRAWING NO.	SHEET 1 OF 1
ABC PROJECT #1111-9999			